

NO.	DATE	DESCRIPTION	BY


RANDALL JONES & ASSOCIATES ENGINEERS, INC.
#9784
1912 E BRANER LANE
AUSTIN, TEXAS 78753
(512) 836-4793

PROJECT: The Park at Blackhawk IV
SHEET: Preliminary Plan (1 of 4)
Storm Drainage Plan (1 of 4)



DATE: July 2014
DRAWN: RLD
CHECKED: JKC
FILE: 1402
SCALE: 1"=100'


SHEET **02**

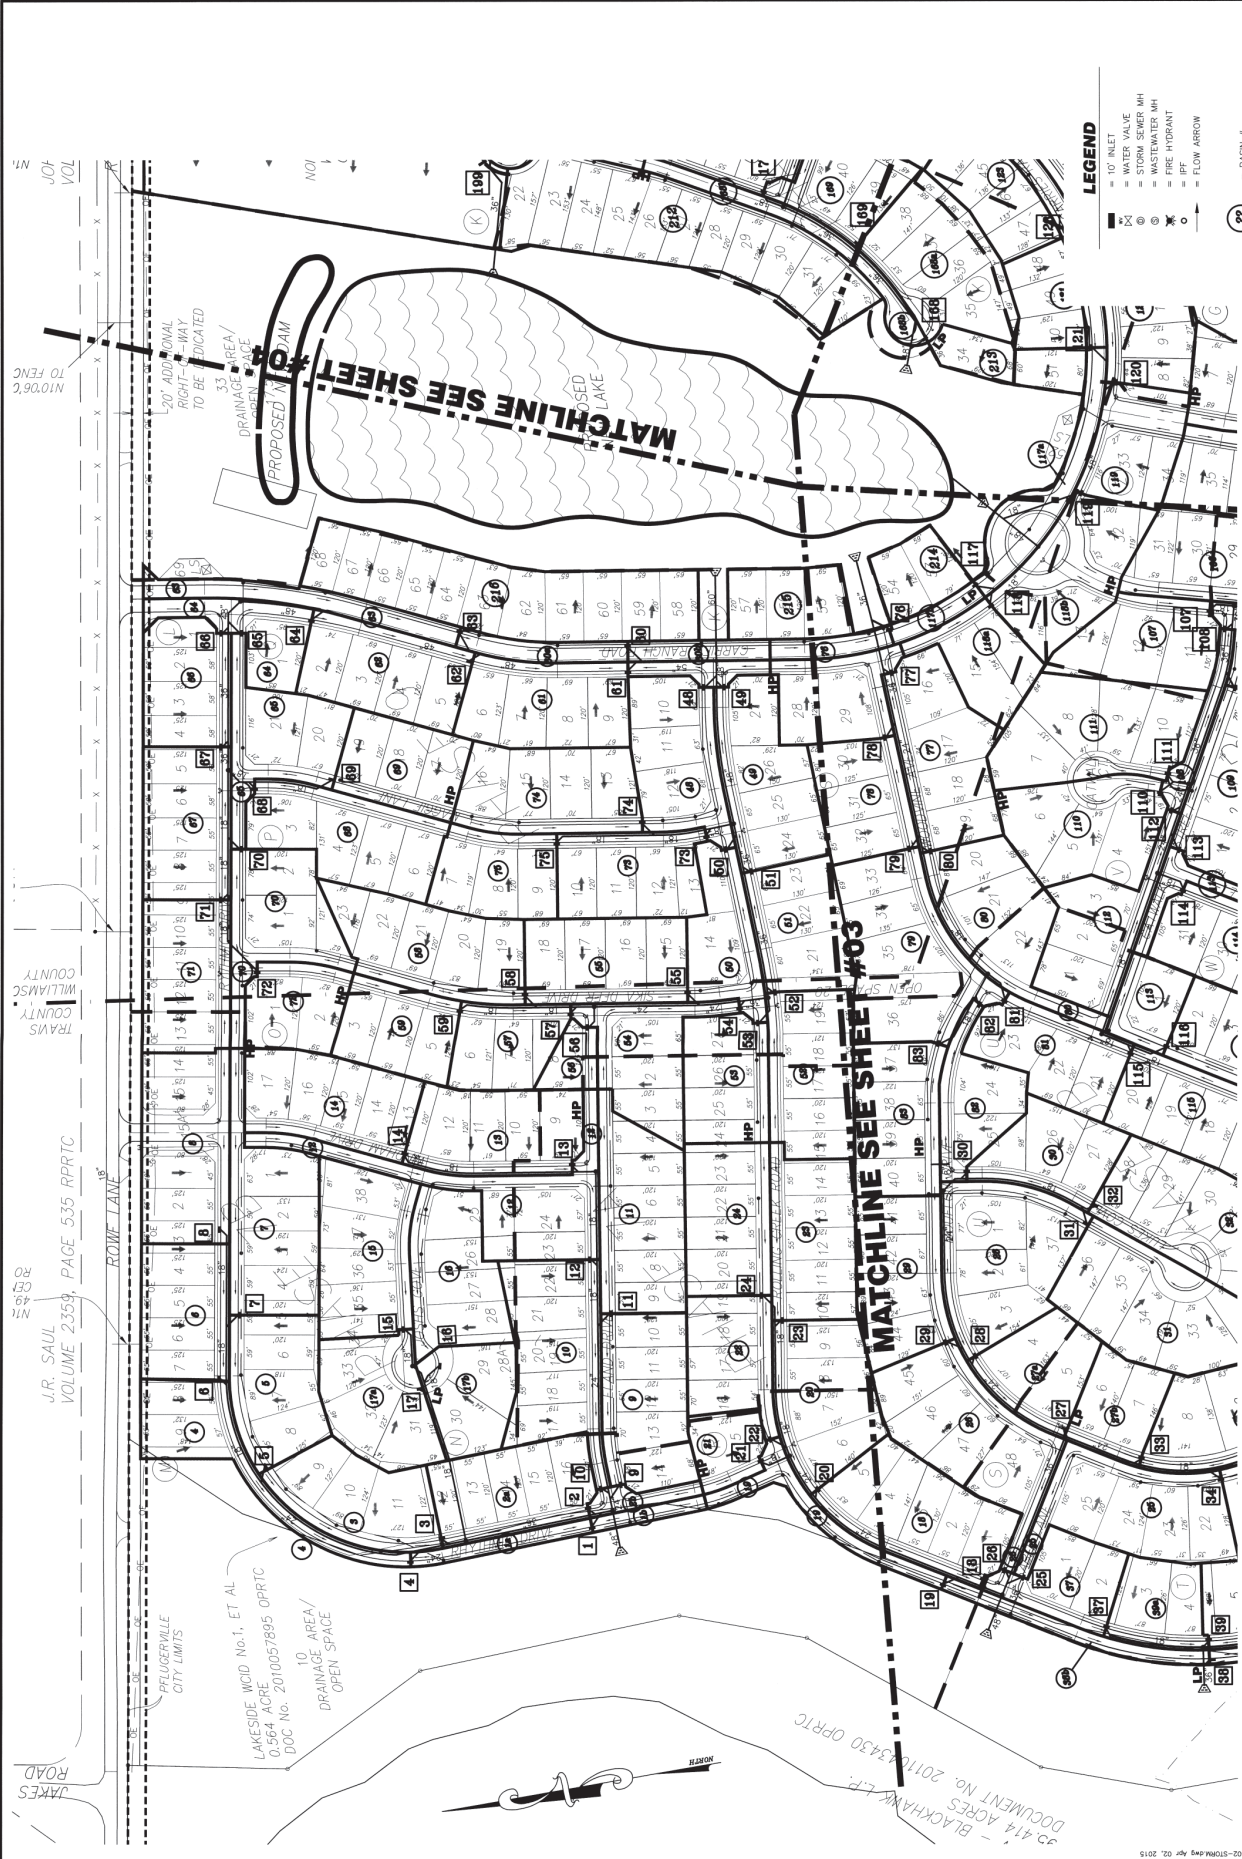


- LEGEND**
- 10" INLET
 - WATER VALVE
 - STORM SEWER MH
 - WASTEWATER MH
 - FIRE HYDRANT
 - FLOW ARROW
 - BASIN #
 - INLET #

SEE DRAINAGE REPORT FOR DRAINAGE CALCULATIONS

J.R. SAUL
VOLUME 2353, PAGE 535 RPRTC
WILLAMSON COUNTY
TRAVIS COUNTY
PILGRIMAGE CITY LIMITS
LAKESIDE WOID No. 1, ET AL
0.564 ACRE
DOC No. 2010057895 OPRTC
DRAINAGE AREA/
10
OPEN SPACE
JAKES ROAD
DOCUMENT NO. 201005430 OPRTC
BLACKHAWK L.P.
35.414 ACRES
R:\JL\1400-1400-1402\1402\1402\1402-1402.dwg Apr 02, 2015

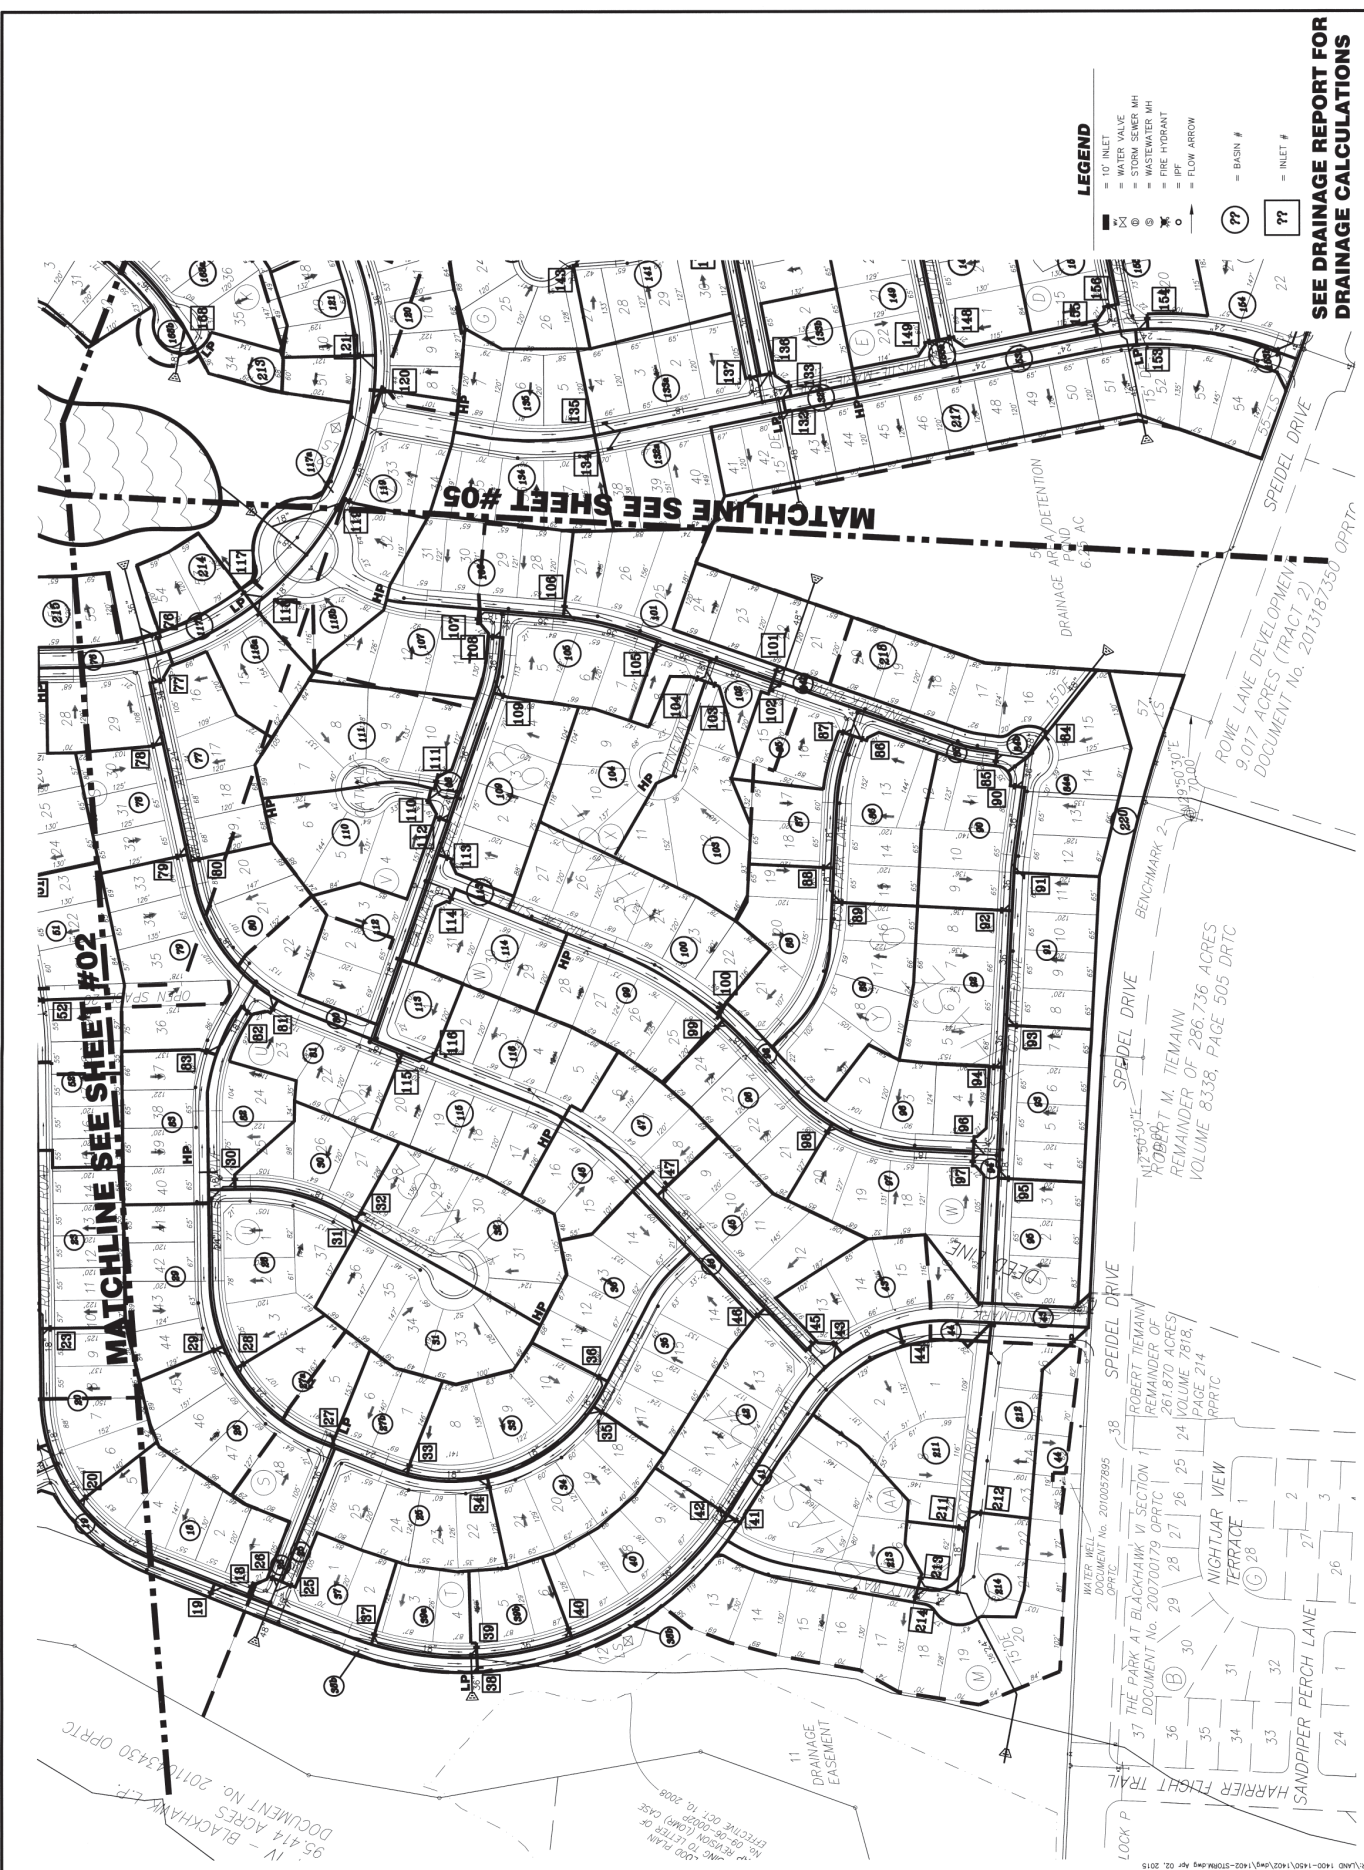

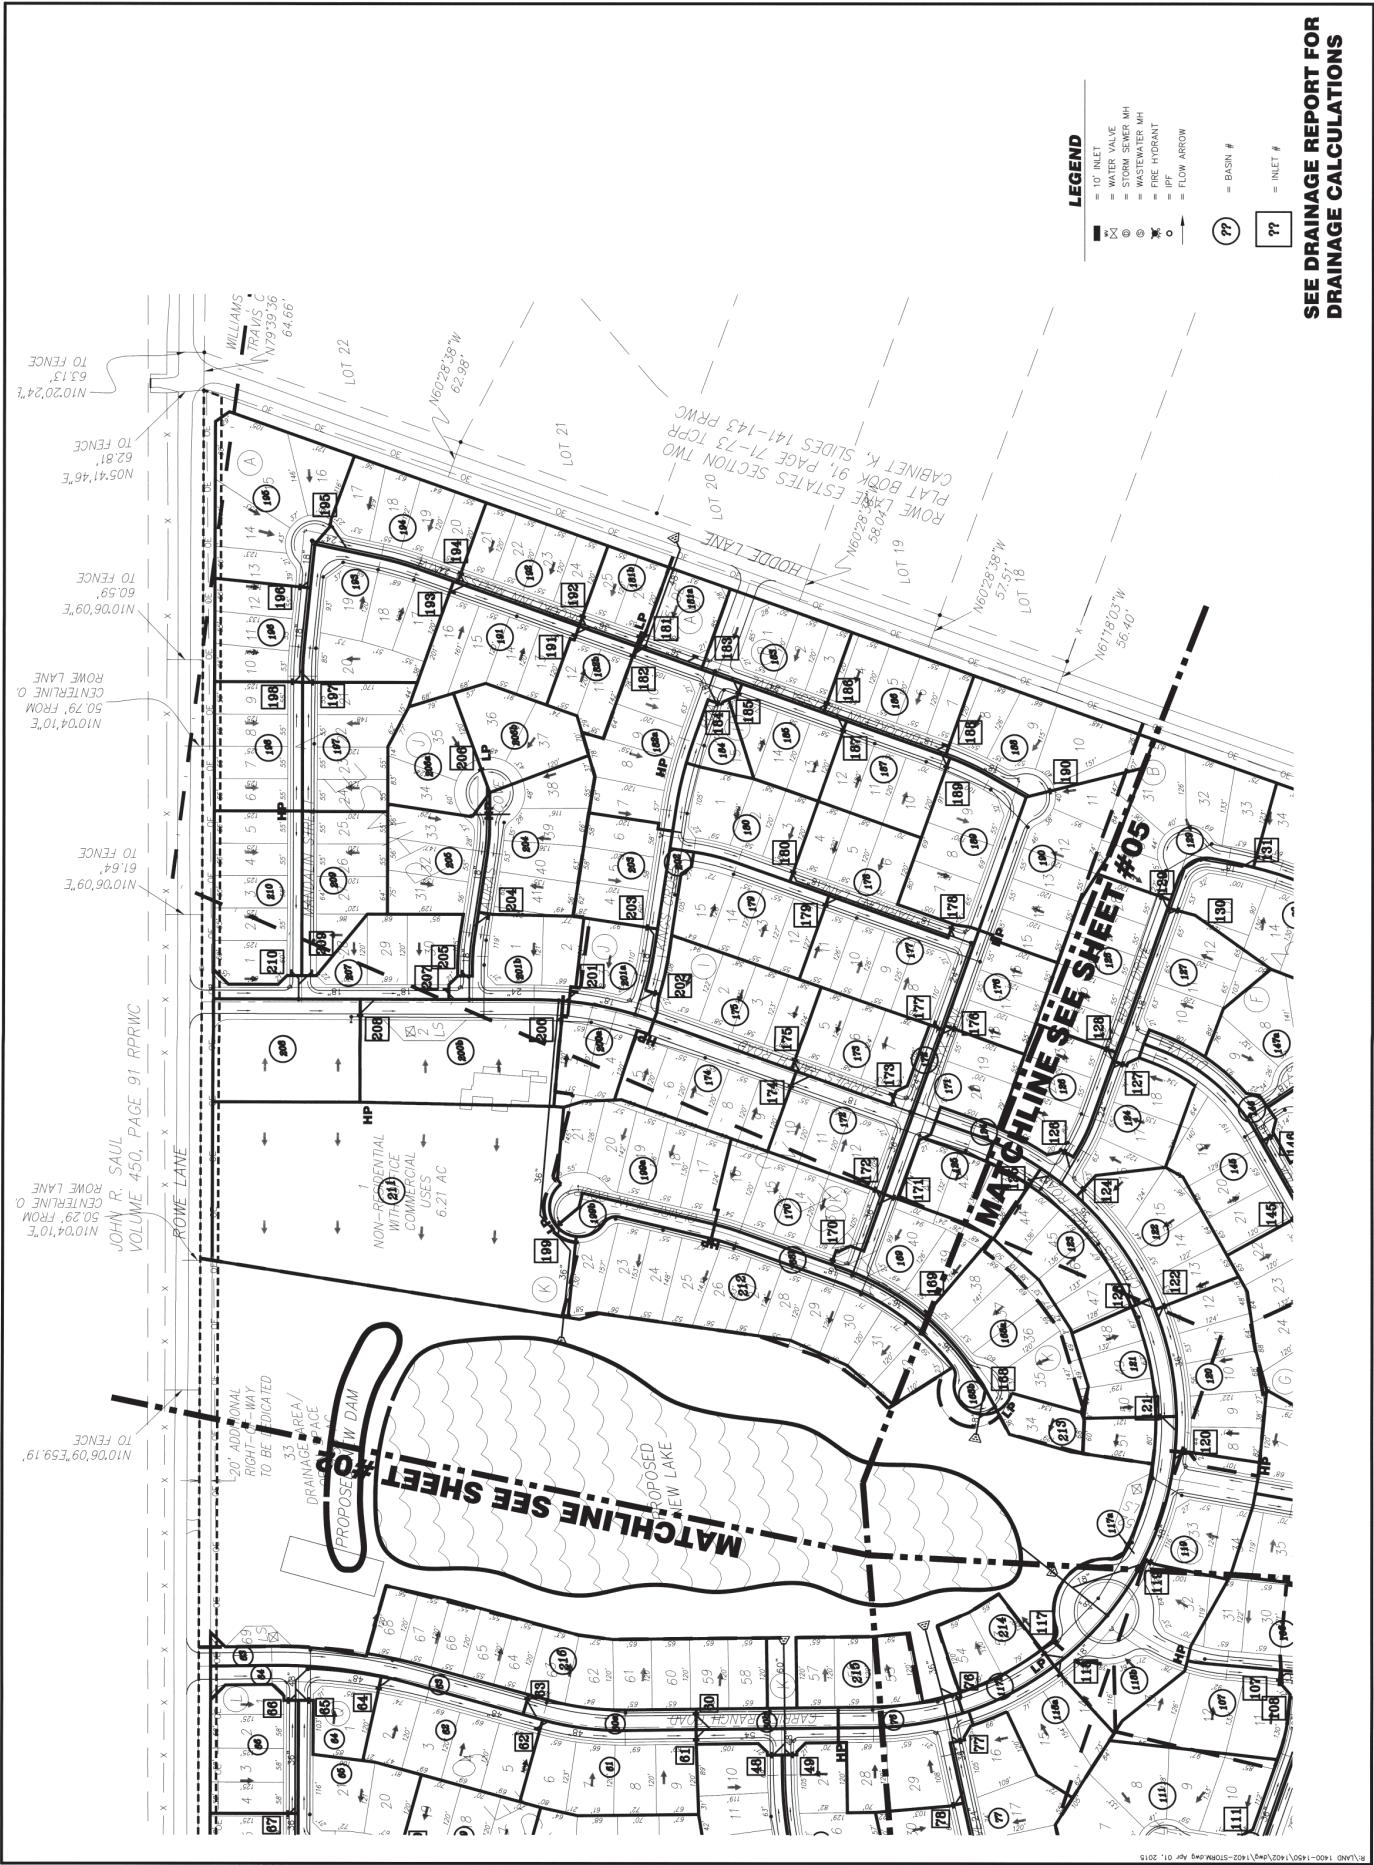

NO.	DATE	DESCRIPTION	BY

PARSONS
JONES &
ASSOCIATES
ENGINEERING
ARCHITECTS

#5754

1212 E. BRAKER LANE
SUITE 100
PORTLAND, OR 97232
(503) 838-4793

PROJECT:

The Park at Blackhawk N

SHEET:

Preliminary Plan


Storm Drainage Plan (4 of 4)



DATE:	JULY 2014
DRAWN:	R.D.
CHECKED:	J.M.C.
FILE:	14002
SCALE:	1"=100'

SHEET

05

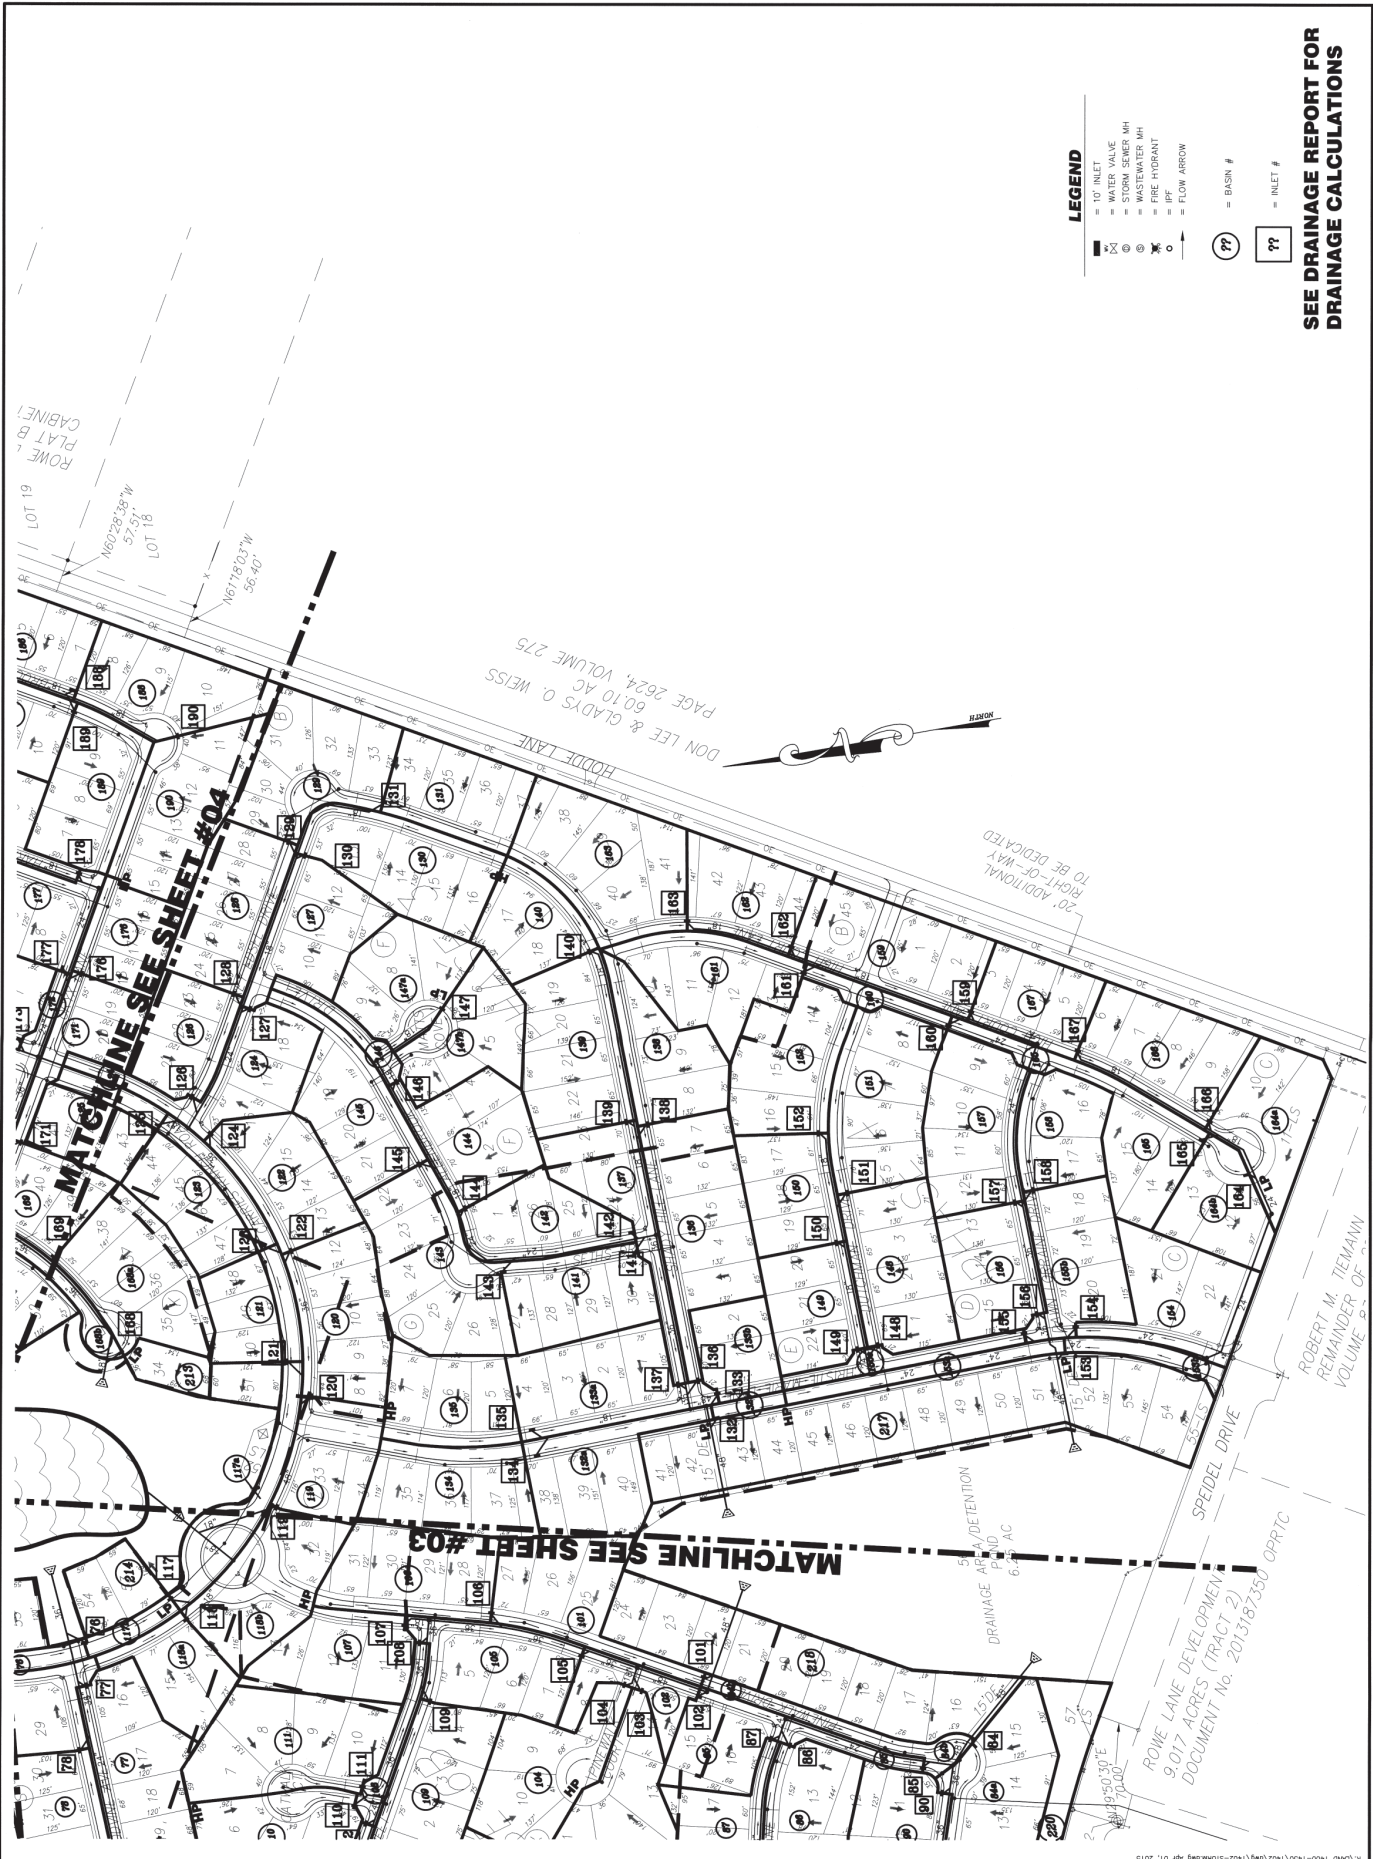

NO.	DATE	DESCRIPTION	BY


RANDALL JONES & ASSOCIATES ENGINEERING INC.
#8784
1902 E. BENDER LANE
MCKINNEY, TEXAS 75069
(972) 838-4793

PROJECT: The Park at Blackhawk
SHEET: Preliminary Plan
Overall Water Distribution Plan (2 of 4)



DATE:	JULY 2014
DRAWN:	RJD
CHECKED:	JAC
FILE:	1402
SCALE:	1" = 100'

SHEET 07

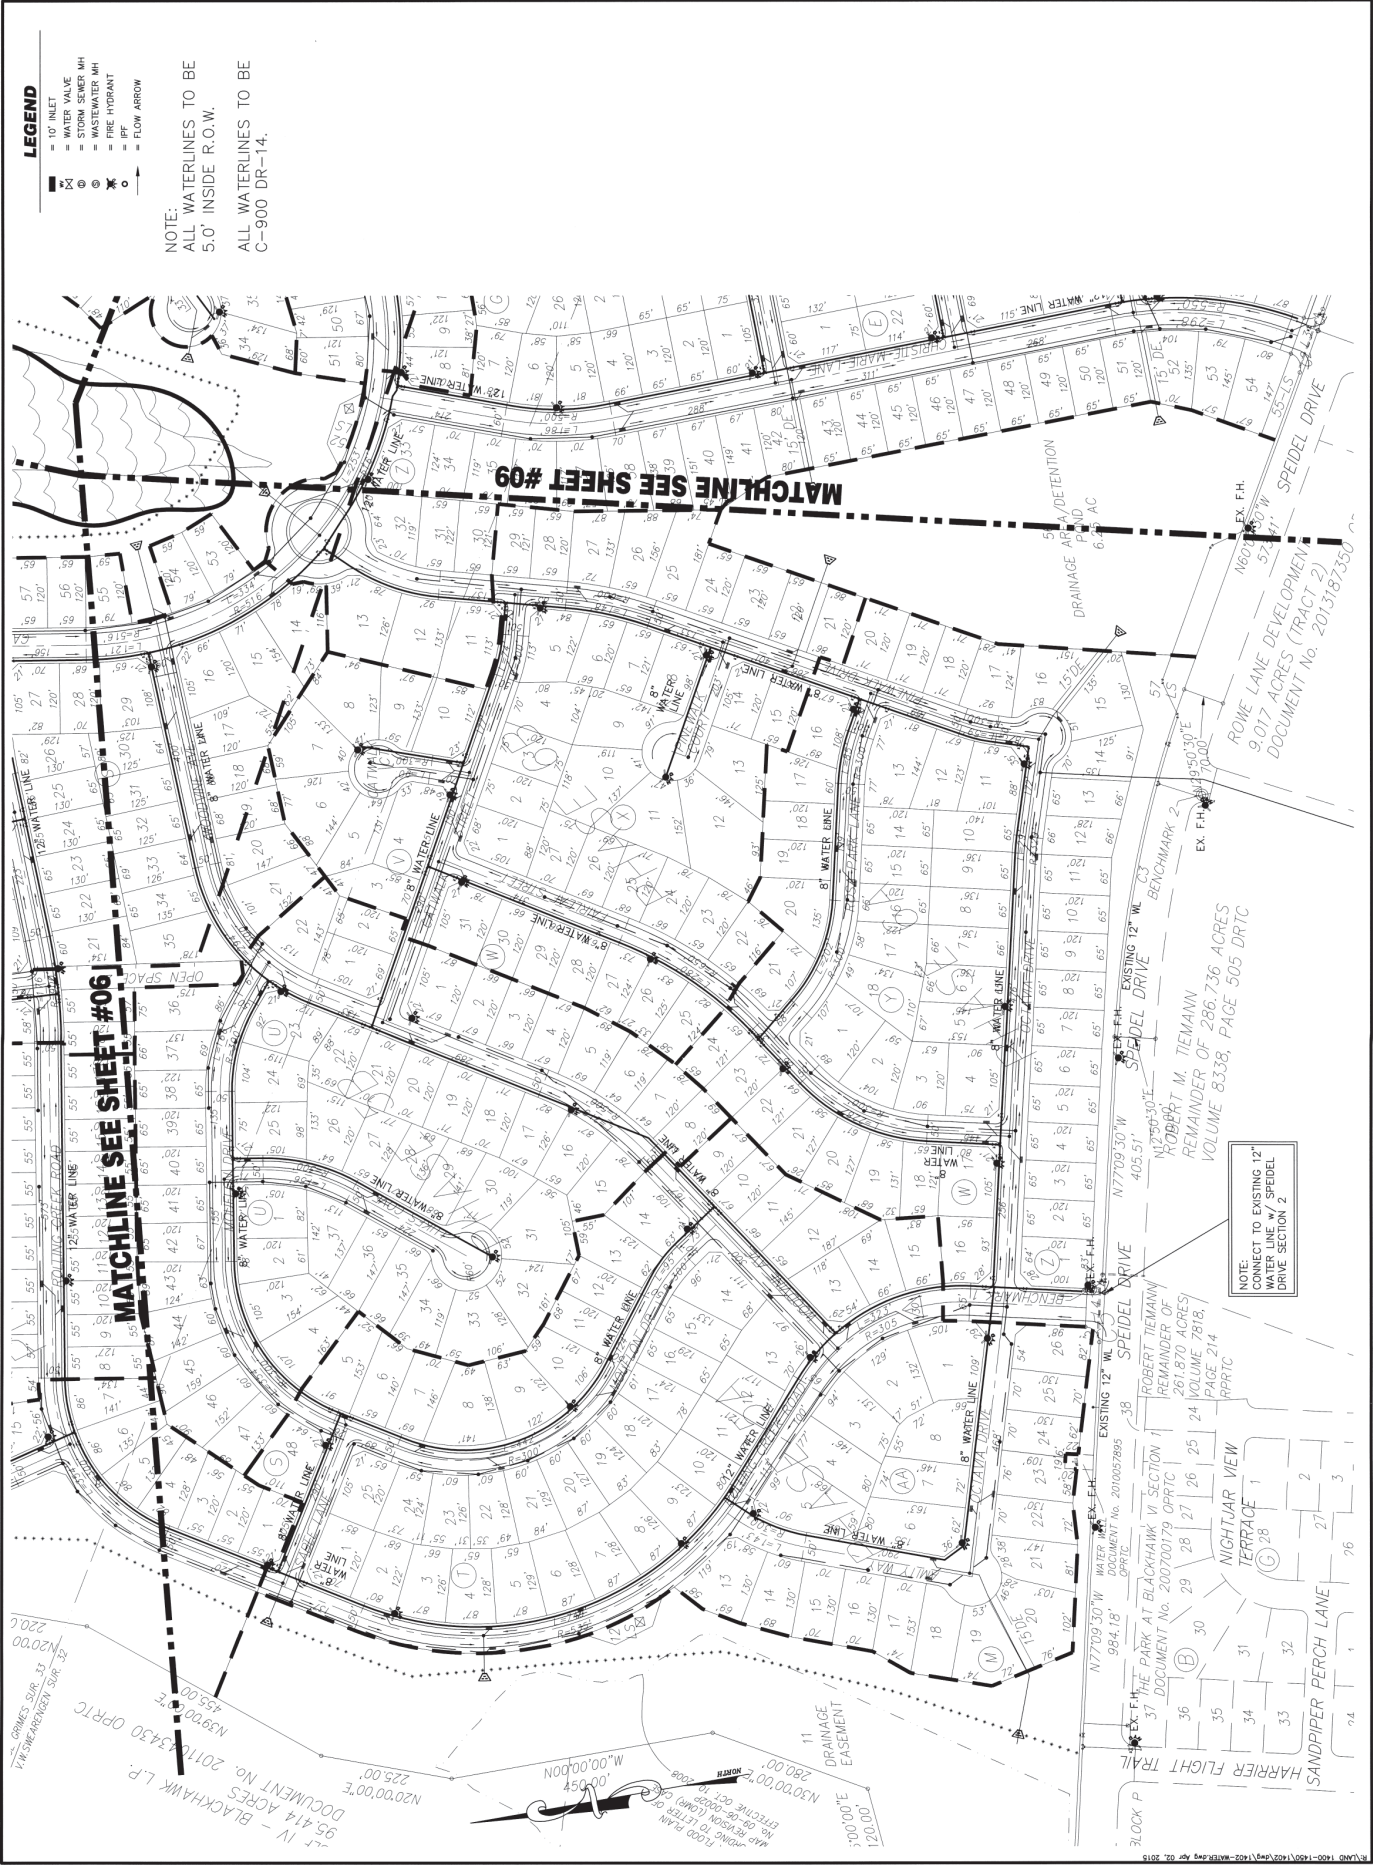

NO.	DATE	DESCRIPTION	BY

PARSONS & ASSOCIATES
ENGINEERING
#6784

1212 E. BRAKER LANE
SUITE 100
PORTLAND, OR 97232
(503) 836-4793

PROJECT: The Park at Blackhawk N

SHEET: Preliminary Plan
Overall Water Distribution Plan (3 of 4)





DATE:	JULY 2014
DRAWN:	R.D.
CHECKED:	J.K.C.
FILE:	1402
SCALE:	1"=100'

SHEET **08**

- LEGEND**
- 10" INLET
 - WATER VALVE
 - STORM SEWER MH
 - WASTEWATER MH
 - FIRE HYDRANT
 - PP
 - FLOW ARROW

NOTE:
ALL WATERLINES TO BE
5.0' INSIDE R.O.W.
ALL WATERLINES TO BE
C-900 DR-14.

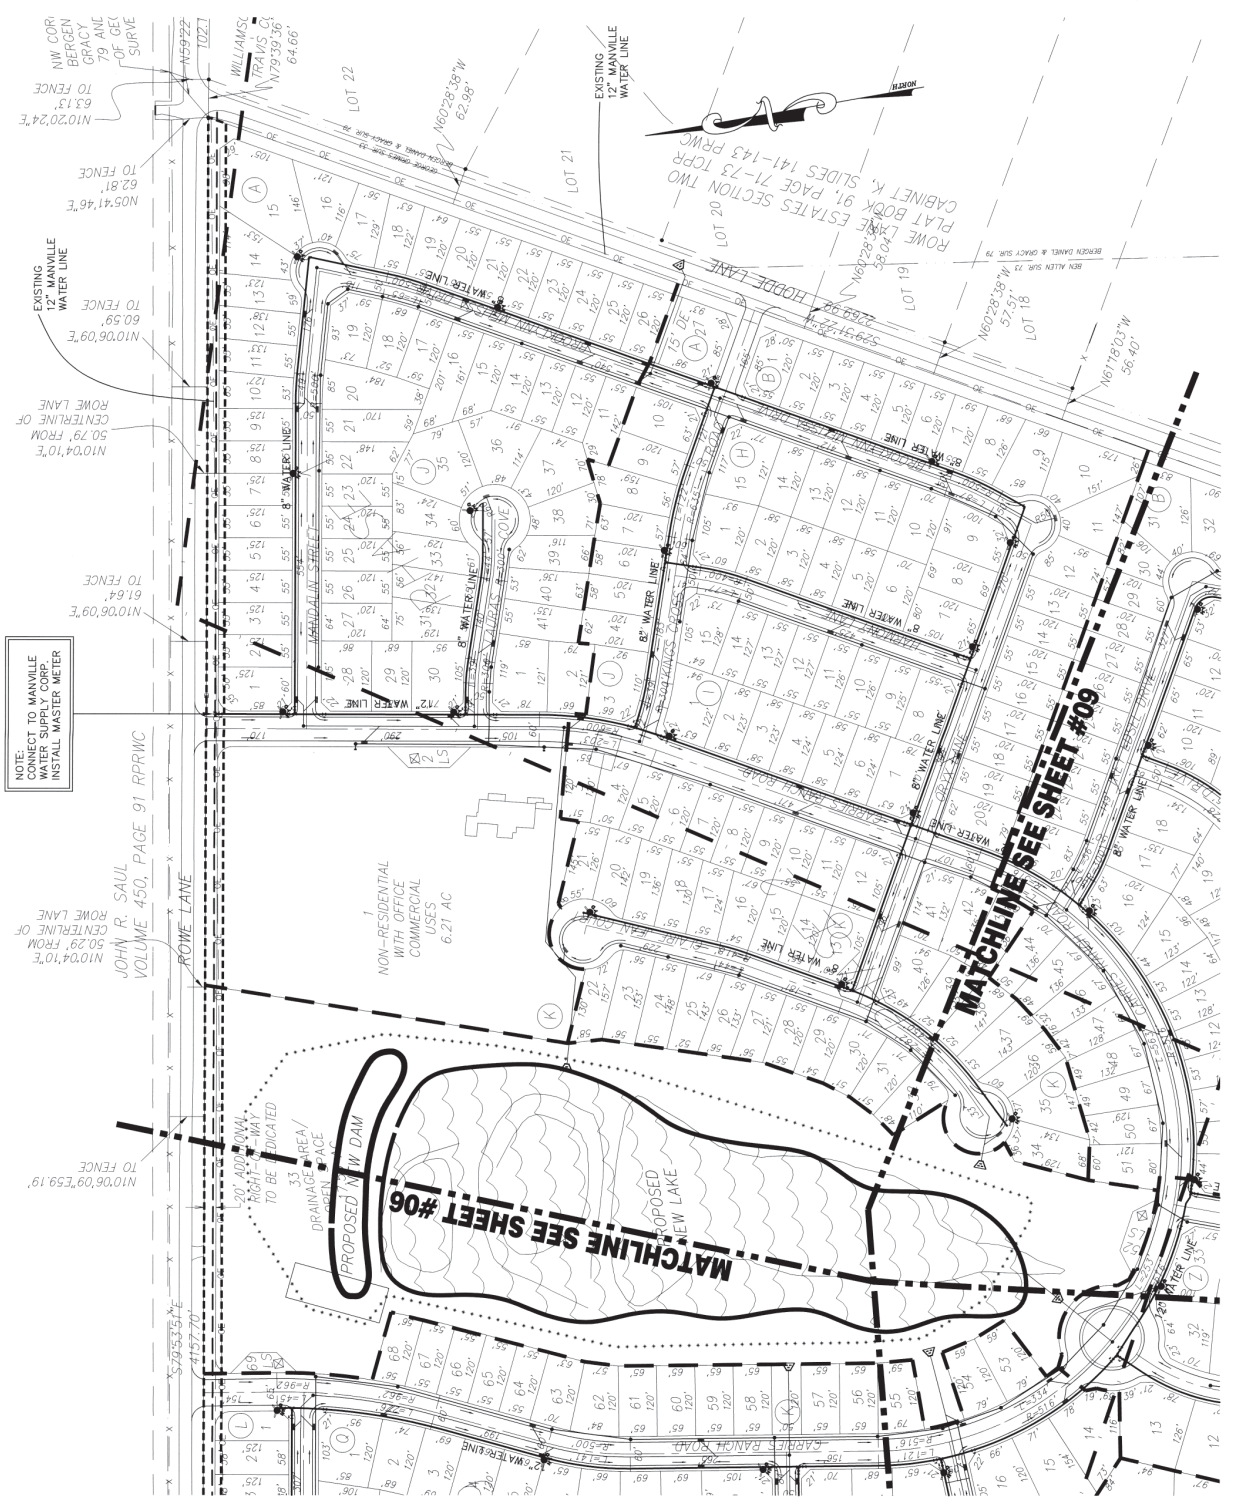

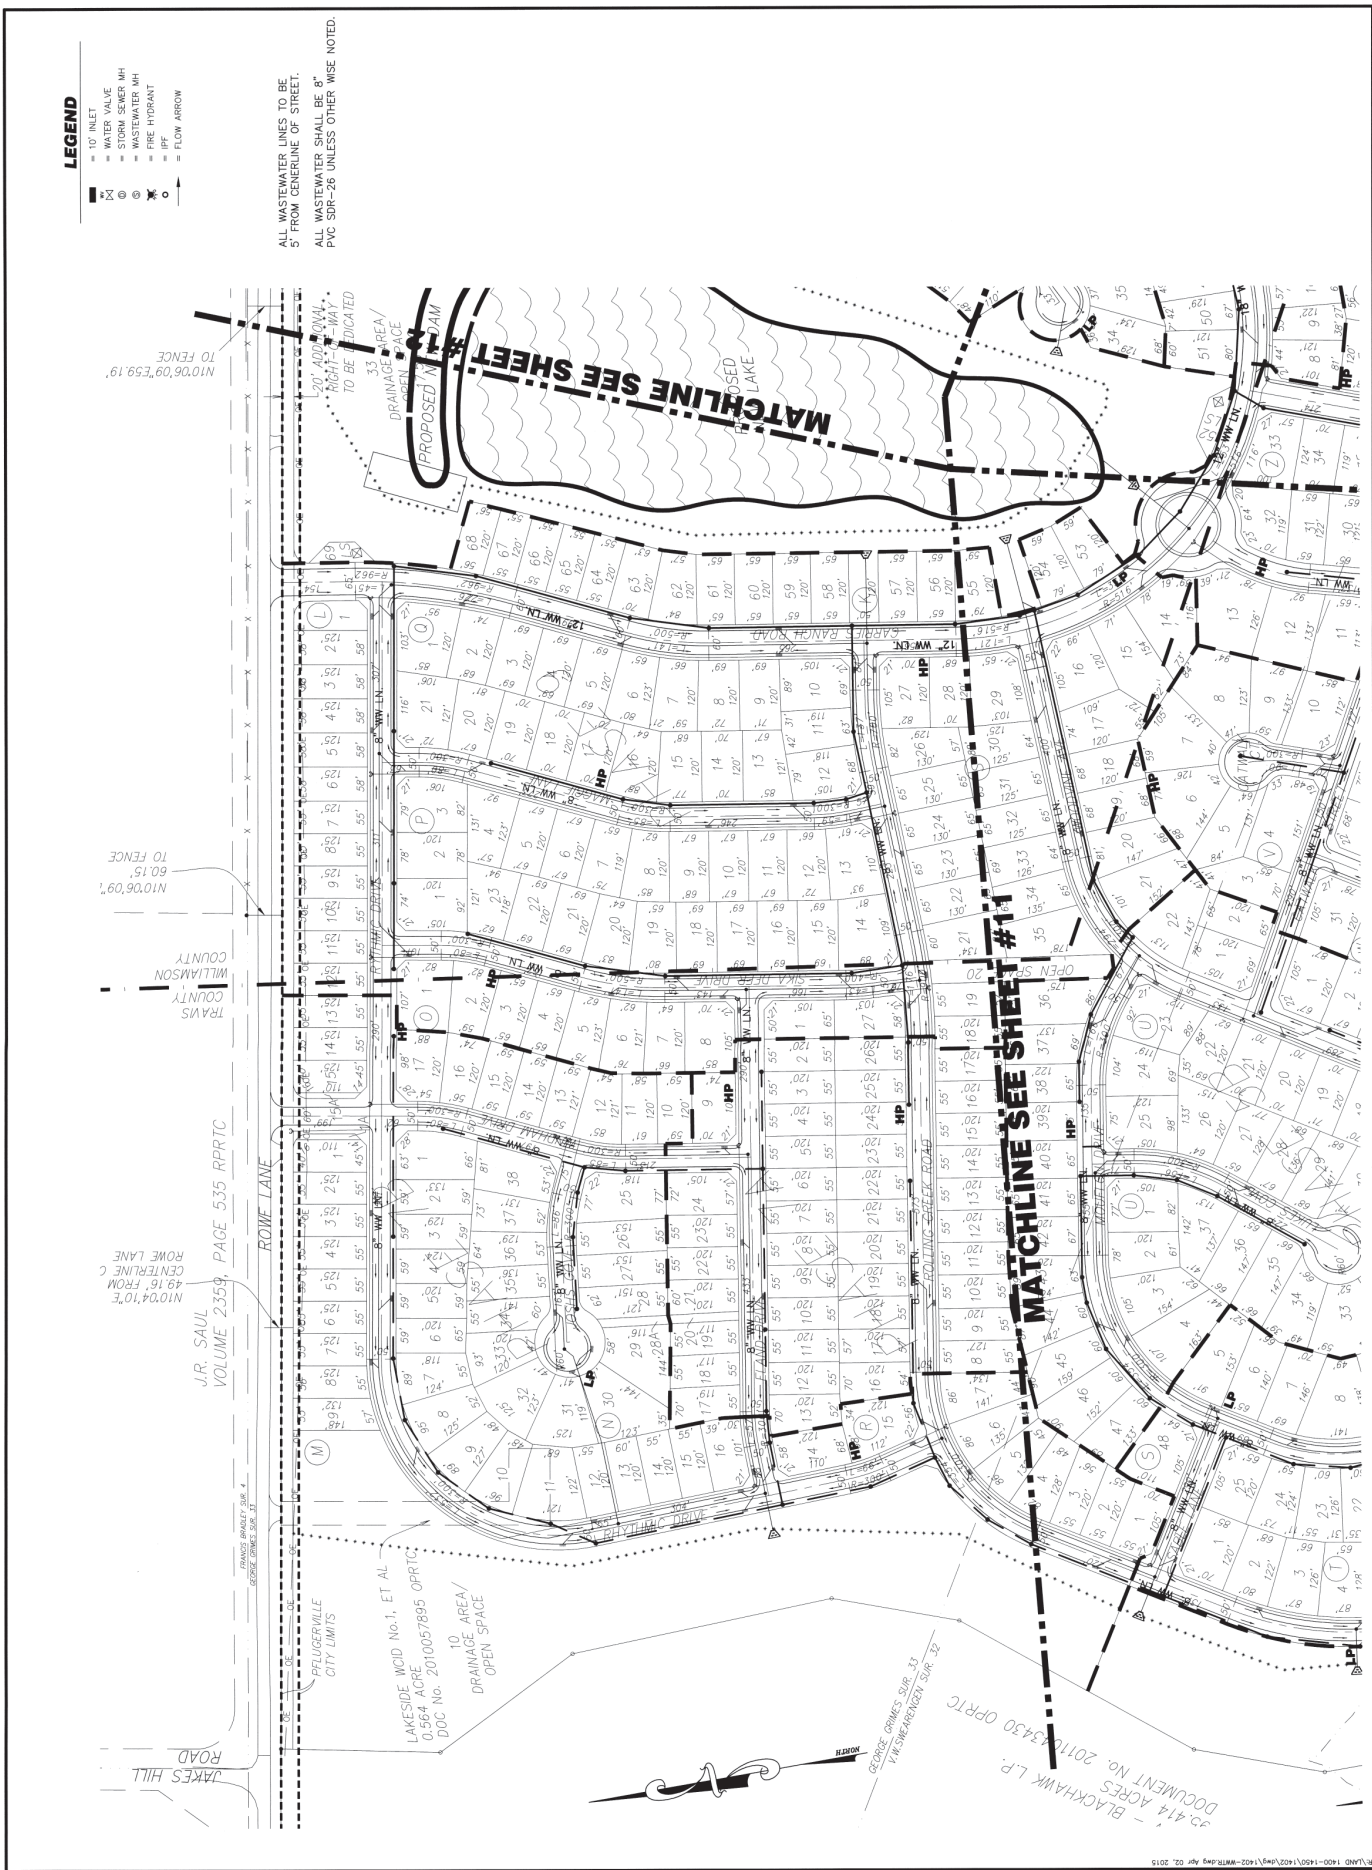



NO.	DATE	DESCRIPTION	BY

RANDALL JONES & ASSOCIATES ENGINEERS, INC.
#8784
2202 E. BRADY LANE
AUSTIN, TEXAS 78755
(512) 838-4783

PROJECT: The Park at Blackhawk IV
SHEET: Preliminary Plan Overall Wastewater Collection Plan (3 of 4)



DATE:	JULY 2014
DRAWN:	RJD
CHECKED:	JMG
FILE:	1402
SCALE:	1"=100'

SHEET 12

